



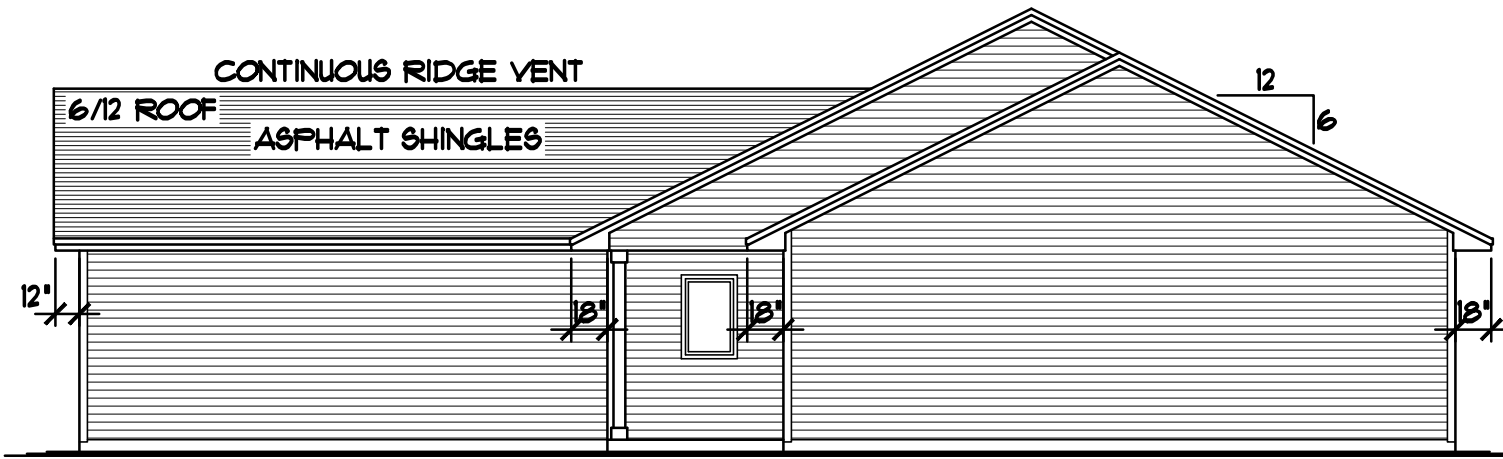


RIGHT ELEVATION 1/8"=1'-0"

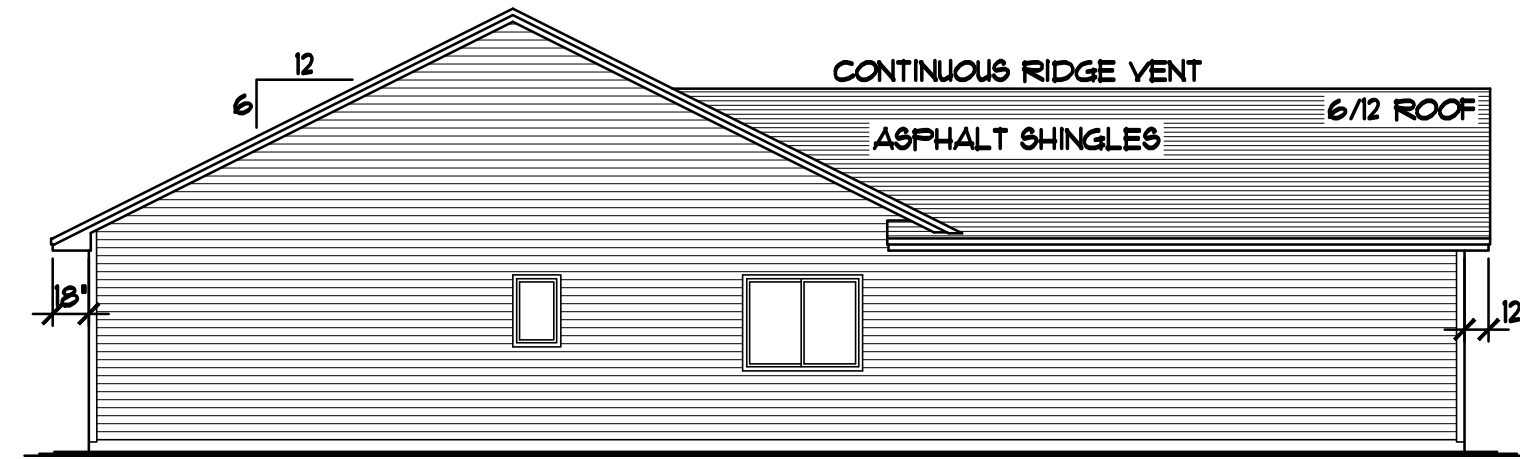

LEFT ELEVATION 1/8"=1'-0"

WINDOW and DOOR PERFORMANCE DATA U-VALUE / SHGC		
① GLIDER UNIT	U-VALUE = 0.30	SHGC = 0.34
② CASEMENT UNIT	U-VALUE = 0.29	SHGC = 0.30
③ FIXED/PICTURE UNIT	U-VALUE = 0.28	N/A
④ SLIDING PATIO DOOR	U-VALUE = 0.28	N/A
⑤ METAL INSUL'D. ENTRY DOOR	U-VALUE = 0.17	SHGC = 0.06

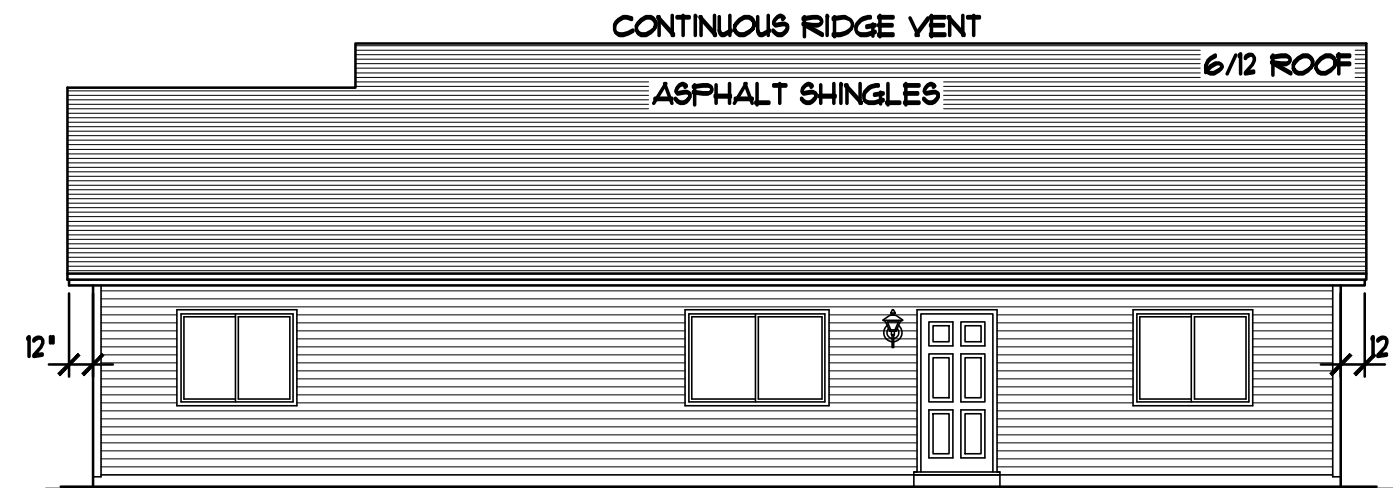


REAR ELEVATION 1/8"=1'-0"

NOTE III
PROVIDE 12' HEEL
• ALL ROOF TRUSSES
UNLESS NOTED OTHERWISE

NOTE III
INSTALL SIMPSON H2.5
HURRICAN TIE at EVERY
ROOF TRUSS, ONE at
EACH END (TYP.)

LEVEL HEIGHT INFORMATION TABLE		
LEVEL	R.C.H.	TOP OF R.O.
MAIN LEVEL	8'-1 1/8"	6'-10 1/2"

- THERMO-TECH WINDOW SIZES SPEC'D.
- VINYL SIDING (TYP.)
- CERTAINTEED OR L.P. SMARTSIDE ONE PIECE CORNER TRIM
- VINYL SHAKE SIDING WHERE SHOWN
- ALUMINUM SOFFITS & FASCIA
- DECO. SHUTTERS WHERE SHOWN
- PROVIDE GUTTERS & DOWNSPOUT (VERIFY POSITION W/ BUILDER)

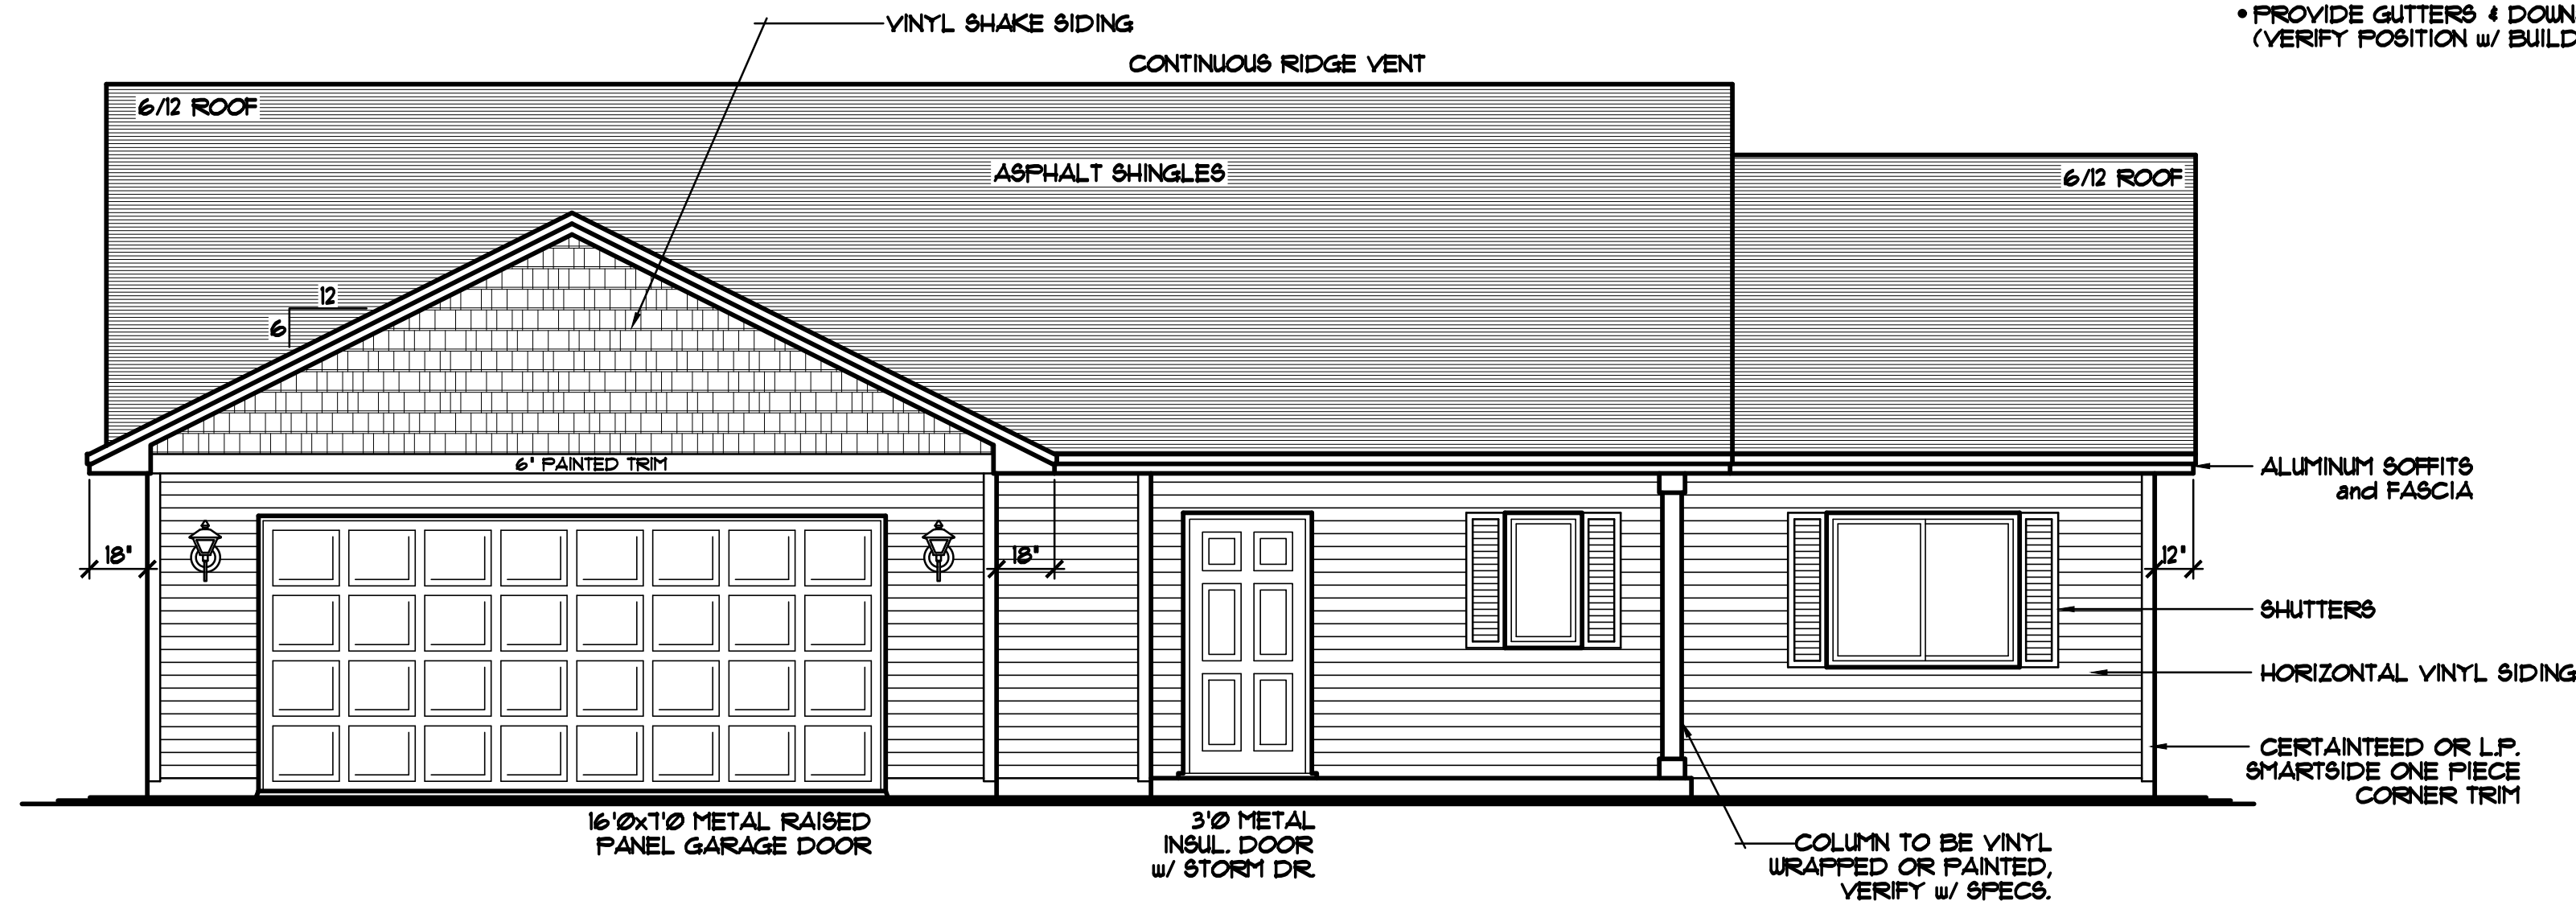

FRONT ELEVATION 1/4"=1'-0"
1647 SQFT. MAIN LEVEL

THE:
WALNUT PLAN
GARAGE LEFT - S.O.G.

REVISIONS	BY
11037	NF.

SPECIAL NOTICE:
CROIX DESIGN and DRAFTING, INC. ACCEPTS NO RESPONSIBILITY FOR ERRORS AND/OR OMISSIONS. THESE DRAWINGS ARE DESIGN CONCEPT ONLY. EVERY EFFORT HAS BEEN MADE TO DESIGN ACCURATELY, BUT THE USER MUST VERIFY ALL DIMENSIONS, MATERIALS, AND CONDITIONS WITH THE GENERAL CONTRACTOR. ALL DETAILS, SUB-CONTRACTORS, AND SUPPLIERS MUST CHECK ALL DETAILS AND DIMENSIONS AND BE RESPONSIBLE FOR ANY CHANGES OR ADJUSTMENTS REQUIRED DURING ACTUAL CONSTRUCTION. NO REPRESENTATION IS MADE OR IMPLIED FOR ACCURACY.

COPYRIGHT NOTICE, ALL RIGHTS RESERVED
THESE ARCHITECTURAL PLANS AND ALL RELATED WORKS ARE PROTECTED BY UNITED STATES COPYRIGHT LAWS, AND MAY NOT BE REPRODUCED, COPIED, OR TRANSMITTED IN ANY FORM OR MANNER WITHOUT THE EXPRESS WRITTEN PERMISSION OF CROIX DESIGN and DRAFTING, INC. CROIX DESIGN and DRAFTING, INC.

DESIGN and DRAFTING BY:


CROIX
DESIGN and DRAFTING, INC.

• ARCHITECTURAL DESIGN and DRAFTING SERVICE •
• HOME PLAN SERVICE • CUSTOM HOMES • REMODELING •
• PHONE: 763.757.5997 • ANDOVER, MINNESOTA •
• WWW.CROIXDESIGN.COM •

BUILT BY:

MILLE LACS BAND of OJIBWE

DRAWN L.V.
CHECKED XX
DATE: 06/23/2017
SCALE: AS NOTED
CADD FILE # 17265-L
SHEET 1 of 7

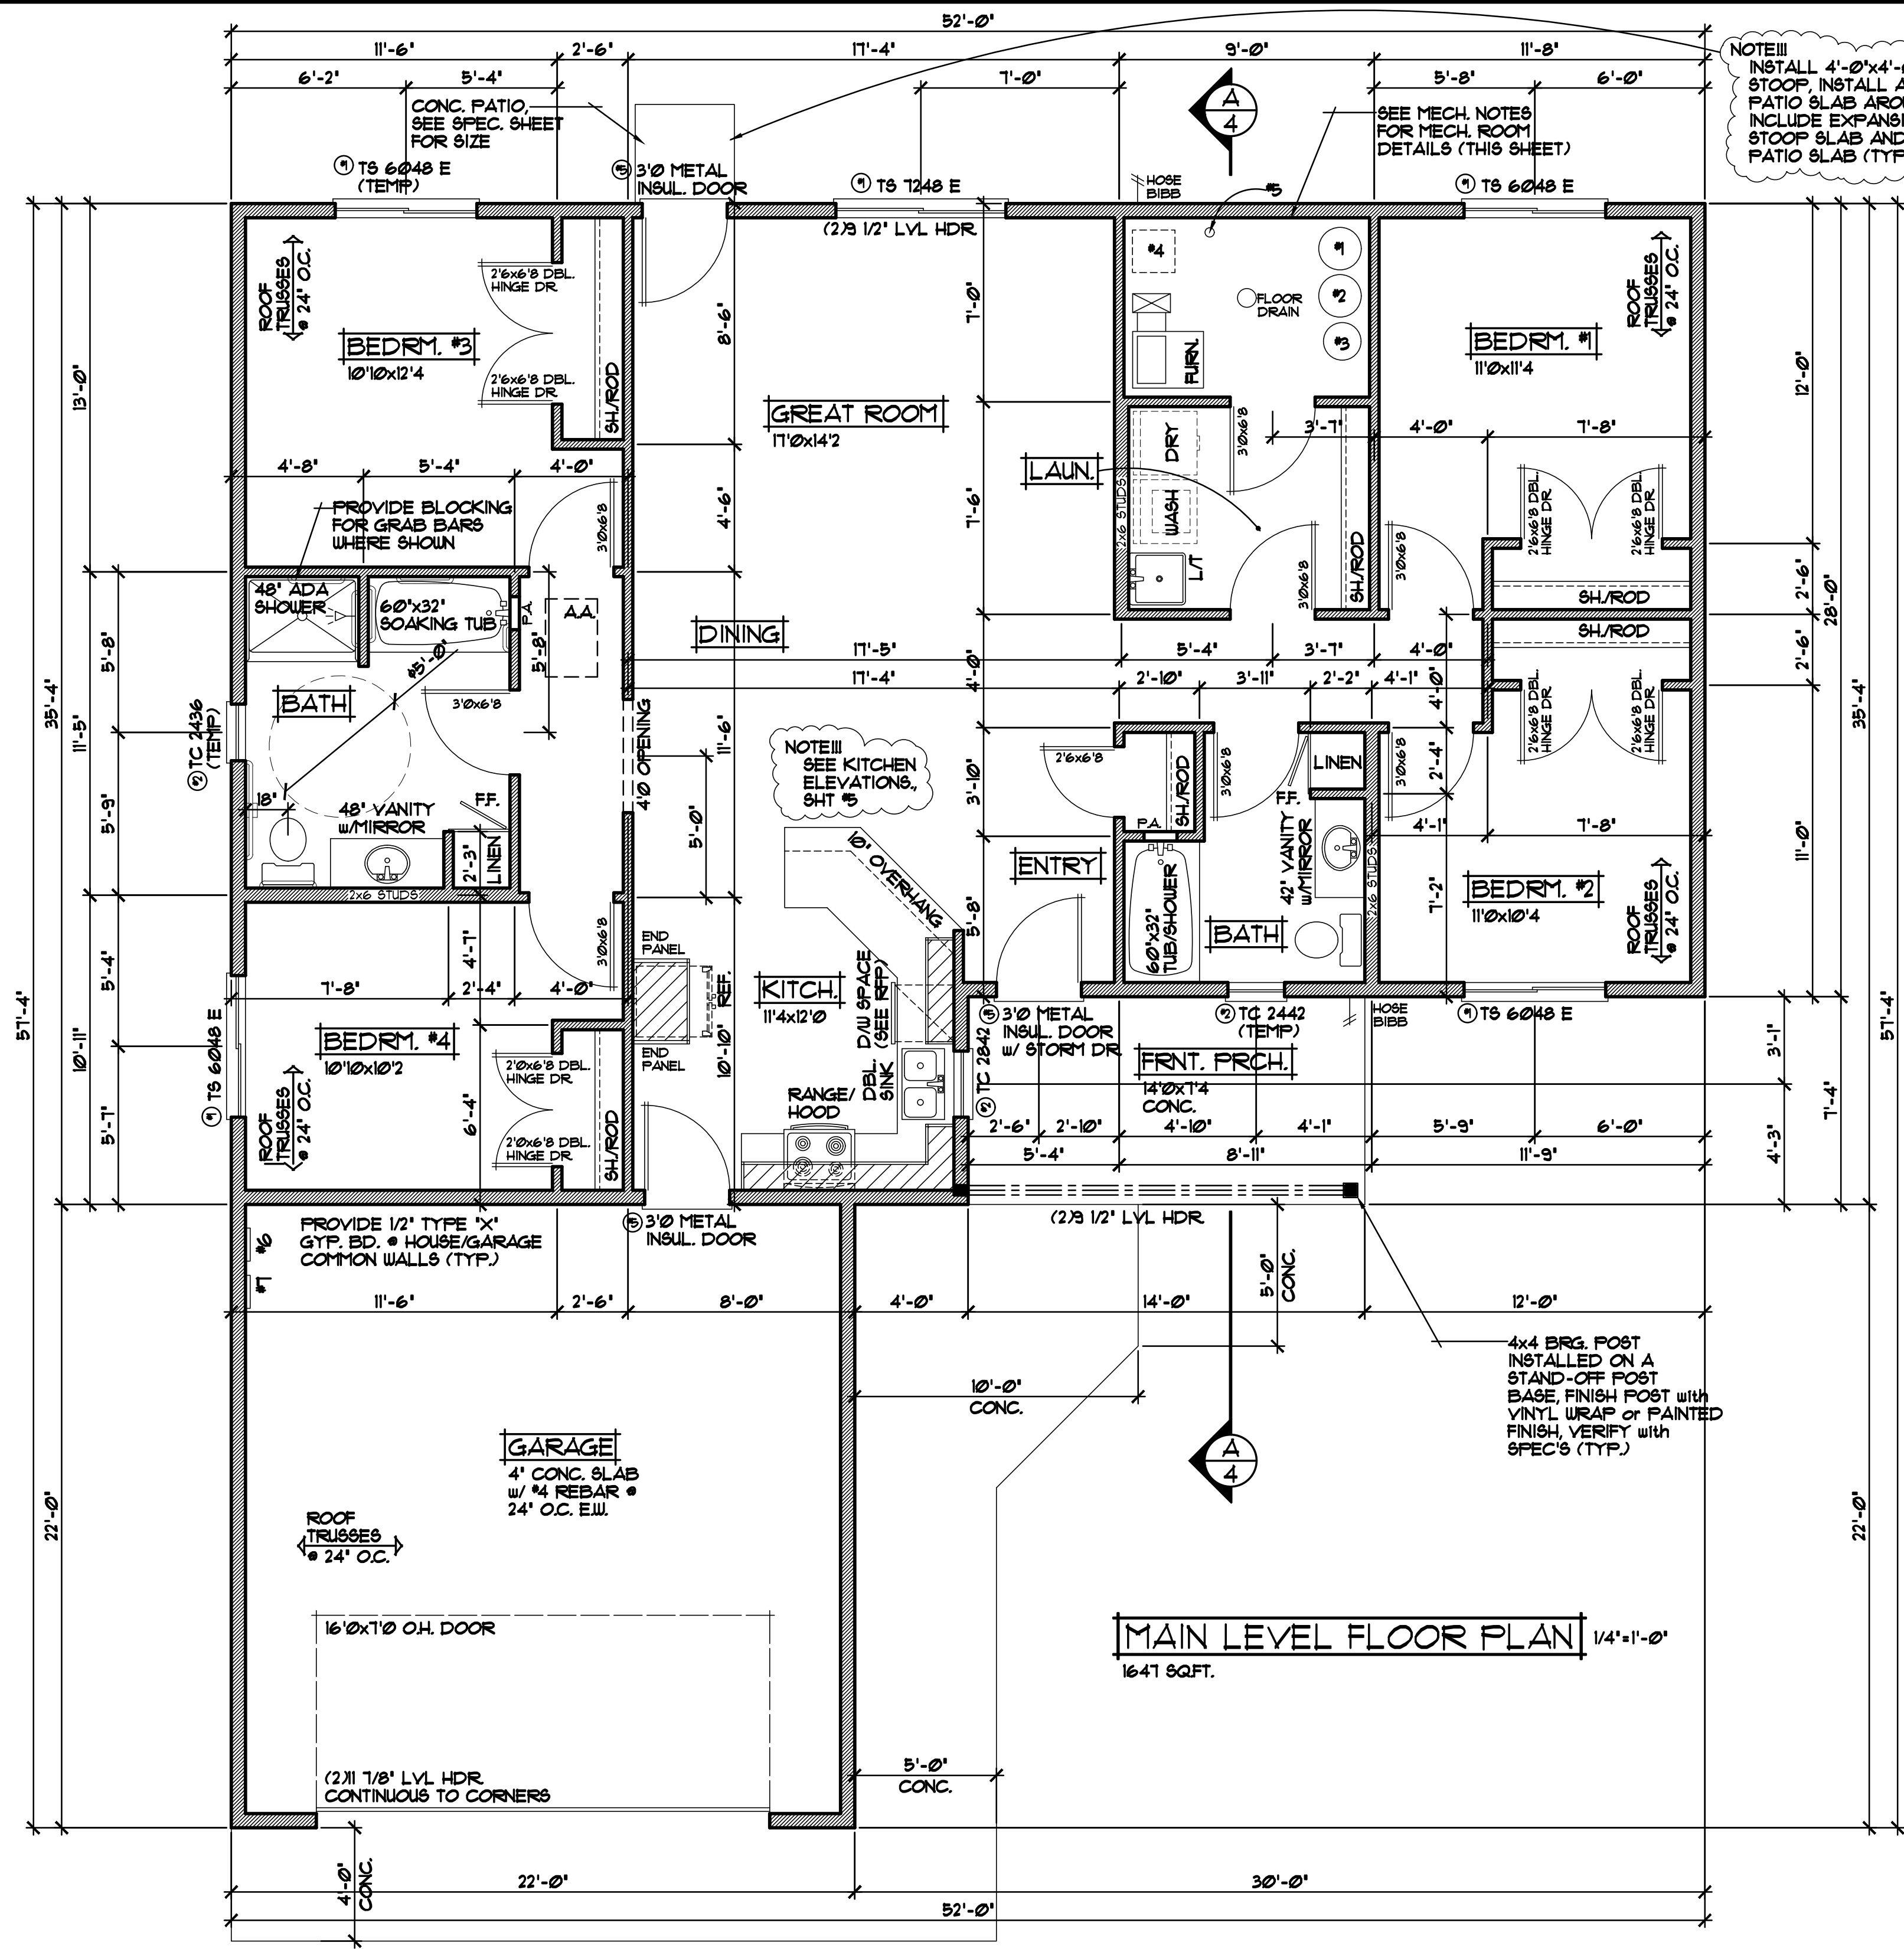

NOTE III
INSTALL 4'-0"x4'-0" CONCRETE
STOOP, INSTALL ANY ADDITIONAL
PATIO SLAB AROUND STOOP AREA,
INCLUDE EXPANSION JOINT BETWEEN
STOOP SLAB AND ANY ADDITIONAL
PATIO SLAB (TYP.)

NOTE III
PROVIDE 12" HEEL
• ALL ROOF TRUSSES
UNLESS NOTED OTHERWISE

NOTE III
INSTALL SIMPSON H2.5
HURRICAN TIE AT EVERY
ROOF TRUSS, ONE AT
EACH END (TYP.)

- MECH. NOTES III
- 1 - WATER HEATER
 - 2 - WATER SOFTENER
 - 3 - WELL PRESSURE TANK
 - 4 - HEAT RECOVERY VENTILATOR
SUMP BASKET BELOW (VERIFY)
 - 5 - RADON PIPE
 - 6 - ELECTRIC PANEL
 - 7 - LOW VOLTAGE PANEL

FRAMING & CONSTRUCTION NOTES

- 8'-1 1/8" PLATE HEIGHT • ENTIRE MAIN LEVEL
(UNLESS NOTED OTHERWISE)
- 8'-1 1/8" PLATE HEIGHT • GARAGE FROM ENTRY
LEVEL SUB FLOOR
- FRAME ALL GARAGE WALLS w/ 2x6 STUDS •
16' O.C. (TYP.)
- PROVIDE DOUBLE HINGED DOORS •
BEDROOM CLOSETS, VERIFY w/ SELECTION
SHEET THAT HOME HAS DOORS, NOT SHEET
ROCK OPENINGS

DOOR & WINDOW NOTES

- THERMO-TECH WINDOWS SPECIFIED, VERIFY
ROUGH OPENING SIZES FOR DOORS &
WINDOWS w/ MANUFACTURER
- ALL WINDOW & DOOR OPENINGS TO HAVE
(2) 2x10 #2 GRADE HEADER or BETTER
(UNLESS NOTED OTHERWISE)
- TOP OF RO. FOR ALL WINDOWS ON
MAIN LEVEL TO BE 6'-10 1/2" FROM
SUB-FLOOR (UNLESS NOTED OTHERWISE)

MAIN LEVEL FLOOR PLAN 1/4"=1'-0"
1647 SQ.FT.

SPECIAL NOTICE:
CROIX DESIGN AND DRAFTING, INC. ACCEPTS NO RESPONSIBILITY FOR ERRORS AND/OR
OMISSIONS. THESE DRAWINGS ARE DESIGN CONCEPT ONLY. EVERY EFFORT HAS BEEN MADE
TO PREPARE ACCURATE DRAWINGS. HOWEVER, THE USER MUST CHECK ALL DIMENSIONS AND
GENERAL CONTRACTOR'S LOCAL CODES AND SUPPLIERS' CATALOGS FOR ANY CHANGES OR
ADJUSTMENTS REQUIRED DURING CONSTRUCTION. NO REPRESENTATION IS MADE OR IMPLIED FOR ACCURACY.


OFFICE: 763.757.5997
FAX: 763.757.4383
ANOKER, MINNESOTA
WWW.CROIXDESIGN.COM



BUILT BY:
MILLE LACS BAND of OJIBWE

NOTE III
INSTALL SIMPSON H2.5
HURRICAN TIE at EVERY
ROOF TRUSS, ONE at
EACH END (TYP.)

NOTE III
PROVIDE 12" HEEL
• ALL ROOF TRUSSES
UNLESS NOTED OTHERWISE

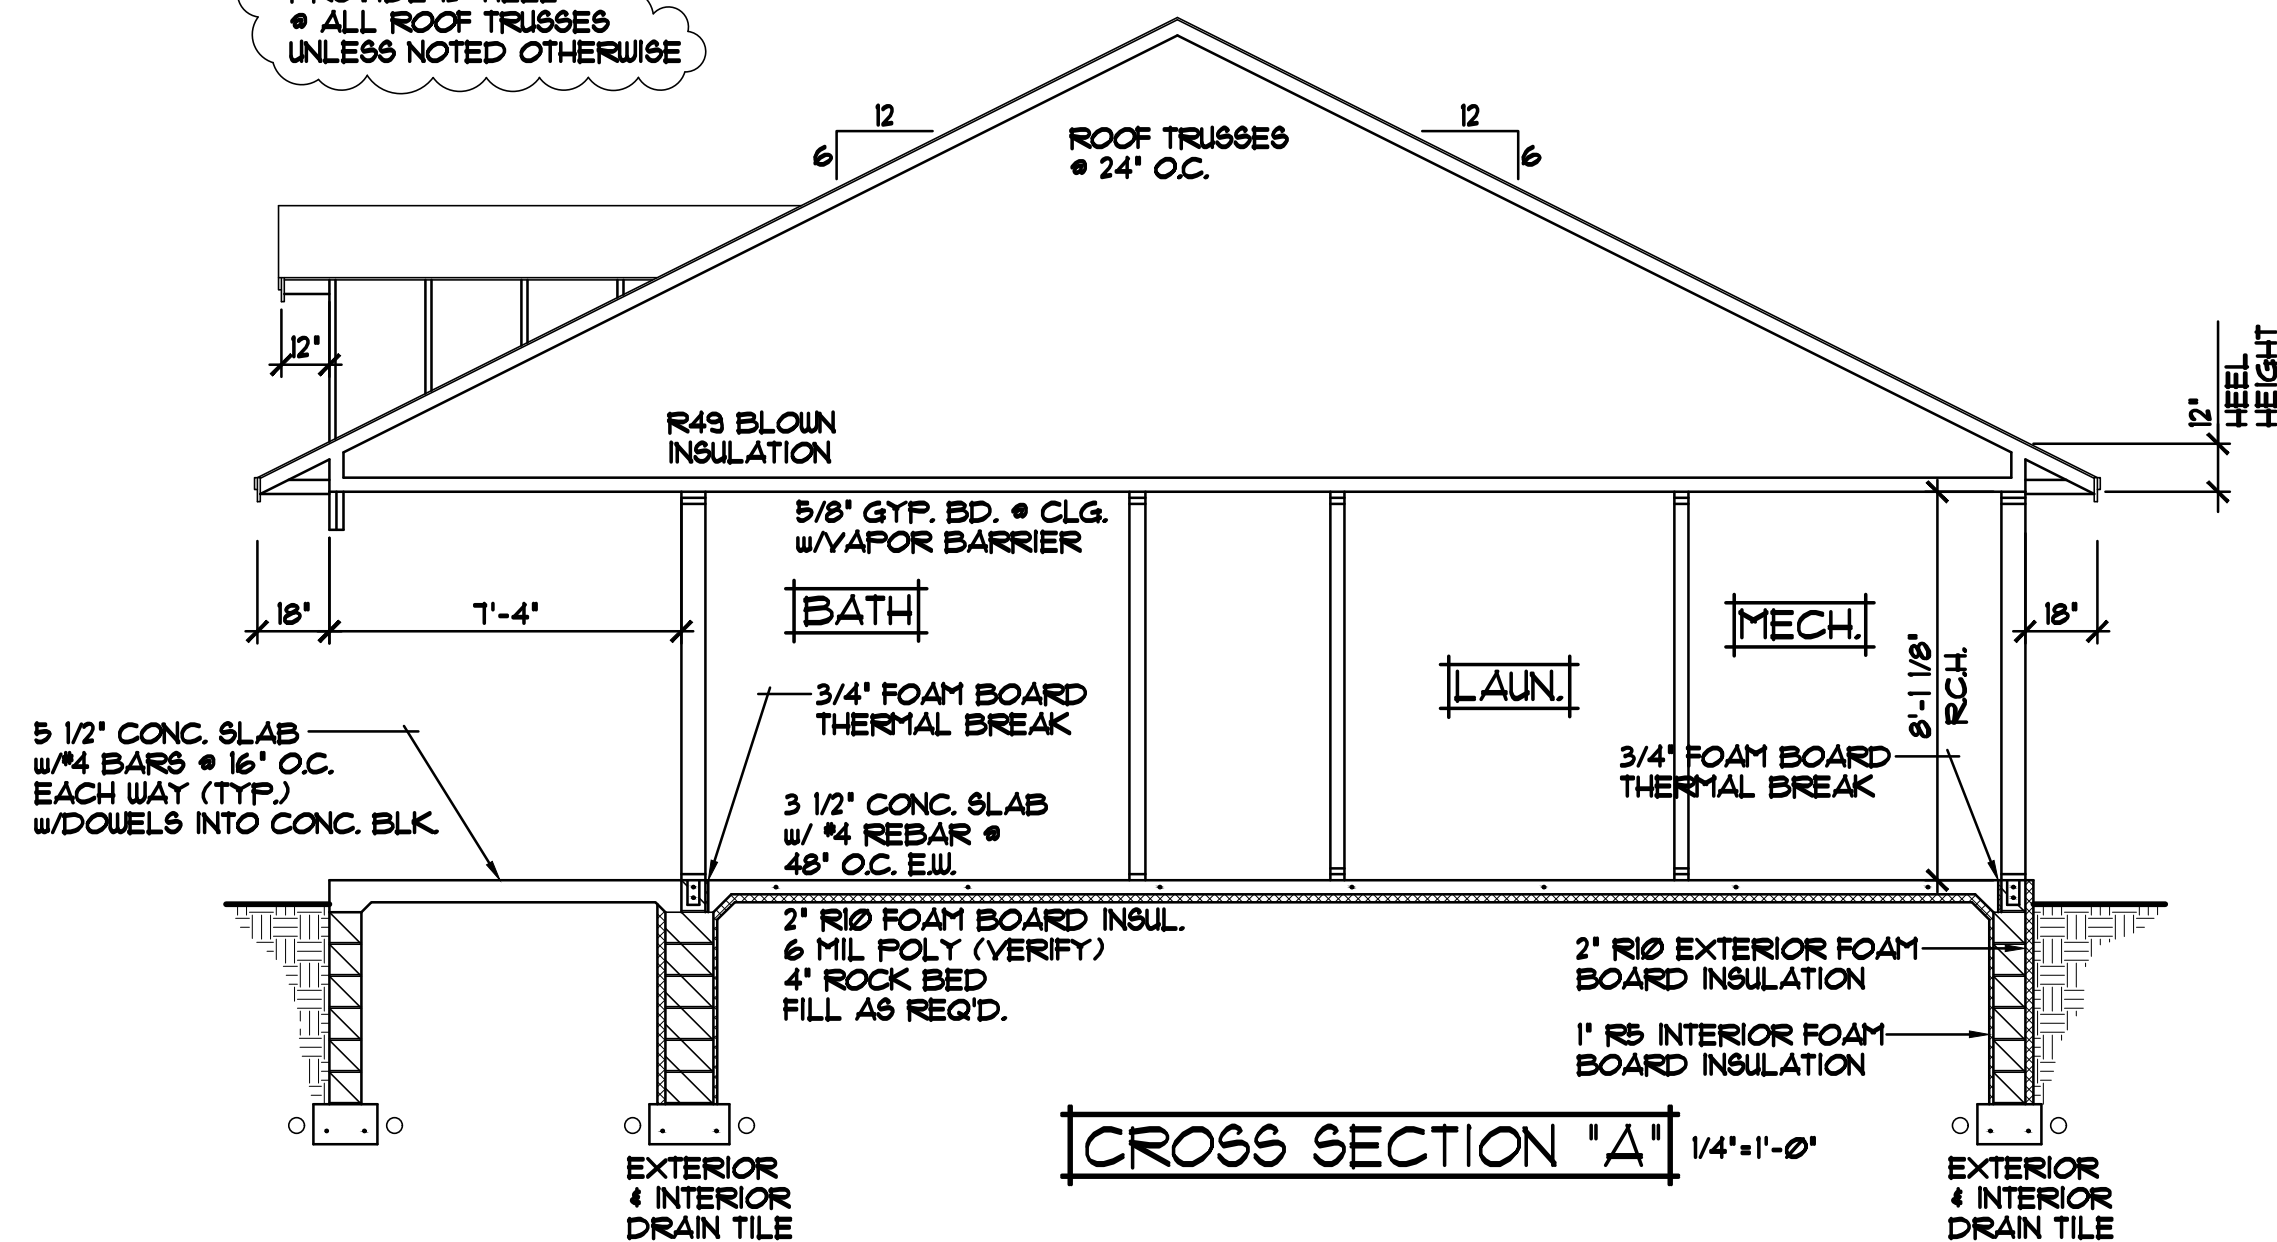

ROOF CONSTRUCTION:

- PREMANUFACTURED ROOF TRUSSES - ENGINEERED BY SUPPLIER - SLOPES VARY - SEE PLAN
- R49 BLOWN FIBERGLASS INSULATION
- 1/150 ROOF VENT AT SOFFITS, 1/150 VENT AT RIDGE
- AIR CHUTE AT EACH TRUSS SPACE
- 1/2" ROOF SHEATHING
- 15# ROOFING FELT
- ICE & WATER MEMBRANE APPLIED 24" PAST EXTERIOR WALL
- ASPHALT SHINGLES

SOFFIT / FASCIA:

- 2x6 SUB-FASCIA
- MAINTENANCE FREE FASCIA COVER
- MAINTENANCE FREE VENTED SOFFIT

WALL CONSTRUCTION:

- HOUSE WRAP
- 1/2" A.P.A. RATED PANEL SHEATHING
- 2x6 STUDS @ 16" O.C.
- WINDOWS PER SPEC'S.
- R-21 FG. BATT INSULATION
- 6 MIL POLY VAPOR BARRIER
- 1/2" GYPSUM BOARD

SILL CONSTRUCTION:

- 2x6 SILL PLATE & SEALER
- 1/2" ANCHOR BOLTS @ 48" O.C.

FOUNDATION INSULATION:

- FOUNDATION EXTERIOR- 2" R-10 RIGID FOAM BOARD INSULATION
- FOUNDATION INTERIOR- 1" R-5 RIGID FOAM BOARD INSULATION

FOUNDATION CONSTRUCTION

- (1) COURSE 6" BOND BEAM BLK. with (2) #4 RE-BAR
- (6) COURSES OF 8" CONC. BLK.
- #4 VERT. RE-BAR @ 12" O.C. with DOWELS INTO CONC. FTG.
- 16"x10" CONC. FTG. w/ (2) #4 BARS

SLAB CONSTRUCTION:

- 3 1/2" POURED CONCRETE FLOOR with #4 REBAR @ 48" O.C. EACH WAY
- 2" R-10 RIGID FOAM BOARD INSULATION UNDER SLAB
- 6 MIL POLY VAPOR BARRIER UNDER SLAB
- UNIFORM LAYER OF 3/4" CLEAN AGGREGATE 4" THICK (MINIMUM)
- SAND FILL AS REQUIRED

ALL HEIGHT CALCULATIONS FOR FOUNDATIONS ARE BASED ON THE USE OF FULL 8" HIGH BLOCK w/ 3/8" JOINTS. IF MODULAR BLOCK IS USED, CONTRACTORS SHOULD ADJUST HEIGHTS ACCORDINGLY.

SPECIAL NOTICE:


CROIX DESIGN and DRAFTING, INC. ACCEPTS NO RESPONSIBILITY FOR ERRORS AND/OR OMISSIONS. THESE DRAWINGS ARE DESIGN CONCEPT ONLY. EVERY EFFORT HAS BEEN MADE TO PREPARE ACCURATE DRAWINGS. HOWEVER, THE USER MUST CHECK ALL DIMENSIONS AND CONDITIONS OF THE PROJECT BEFORE CONSTRUCTION. THE USER MUST CHECK ALL DIMENSIONS AND CONDITIONS OF THE PROJECT BEFORE CONSTRUCTION. THE USER MUST CHECK ALL DIMENSIONS AND CONDITIONS OF THE PROJECT BEFORE CONSTRUCTION. NO REPRESENTATION IS MADE OR IMPLIED FOR ACCURACY.

OFFICE: 763.757.5997
FAX: 763.757.4383
ANDOVER, MINNESOTA
WWW.CROIXDESIGN.COM


CROIX
DESIGN & DRAFTING, INC.

BUILT BY:
MILLE LACS BAND of OJIBWE


SHEET
4
of 7
CADD FILE #
17265-L

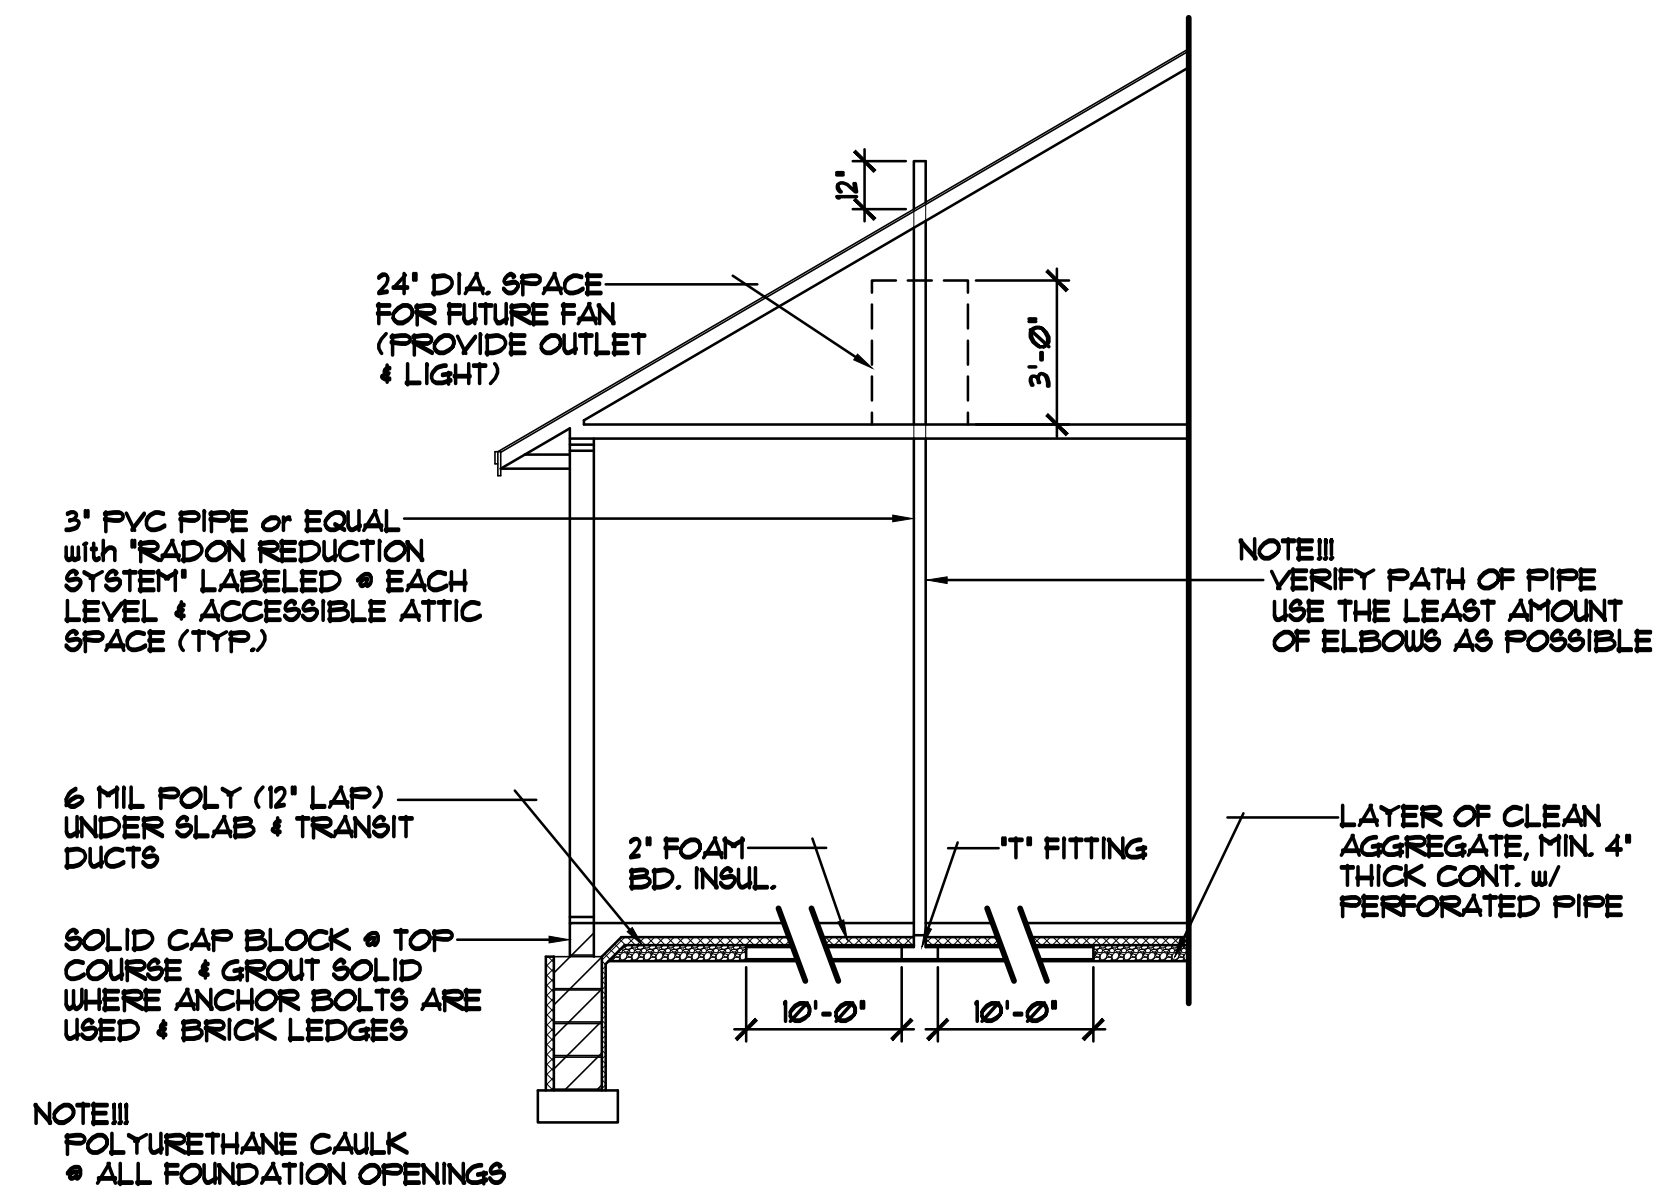


PASSIVE RADON MITIGATION SYSTEM DETAIL

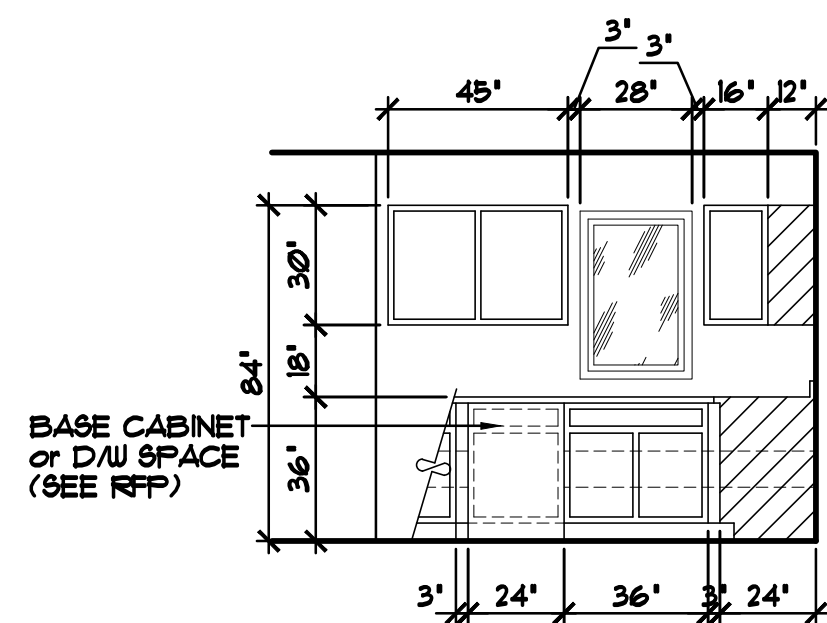

KITCH. CAB. ELEVATIONS 1/4"=1'-0"

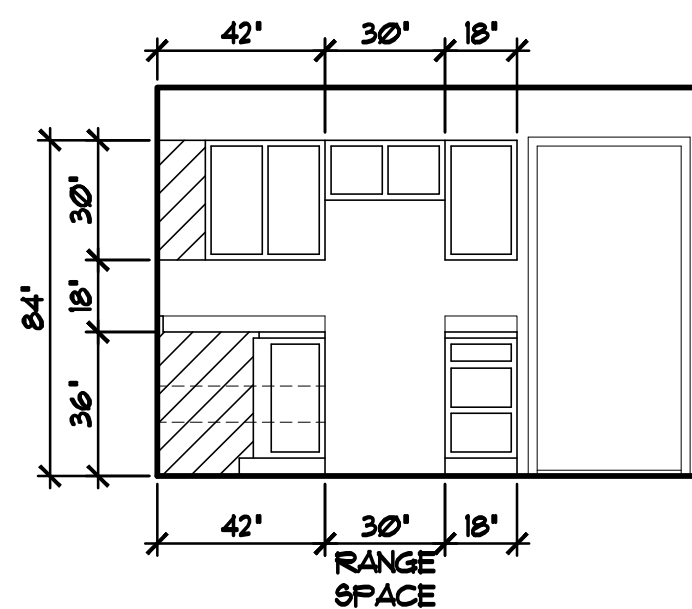


KITCH. CAB. ELEVATIONS 1/4"=1'-0"

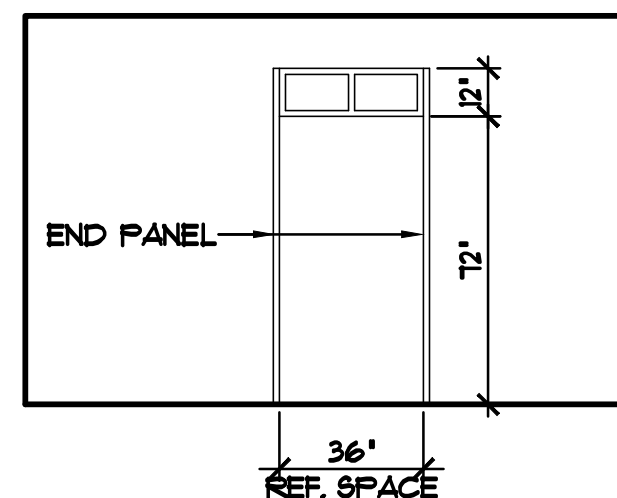


KITCH. CAB. ELEVATIONS 1/4"=1'-0"


NOTE III
DRAWN BREAKLINES REPRESENT CHANGE IN ANGLE @ KITCH. PENN. DIMENSIONS SHOW ACTUAL WIDTH OF CAB. FACE

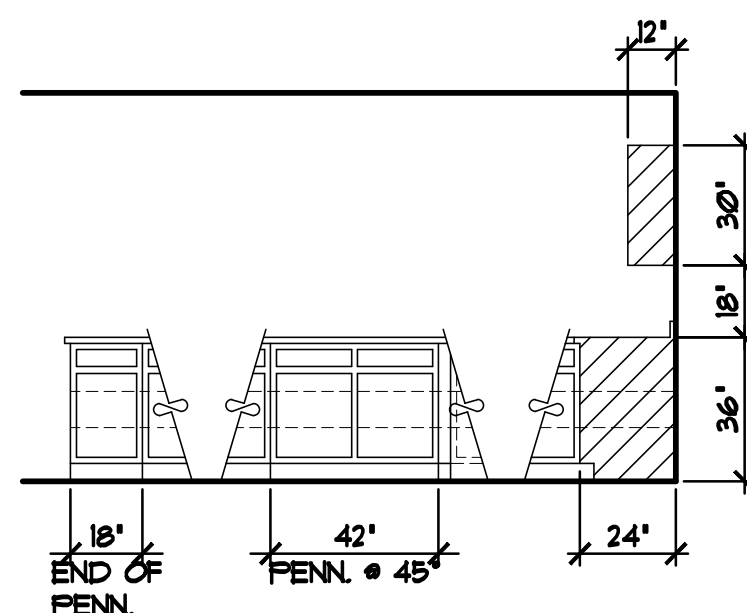

KITCH. CAB. ELEVATIONS 1/4"=1'-0"

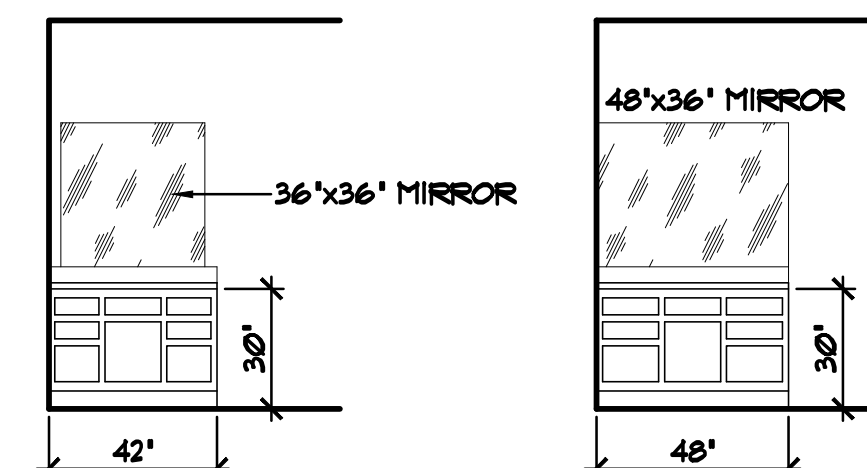

BATH VANITY ELEVATIONS 1/4"=1'-0"

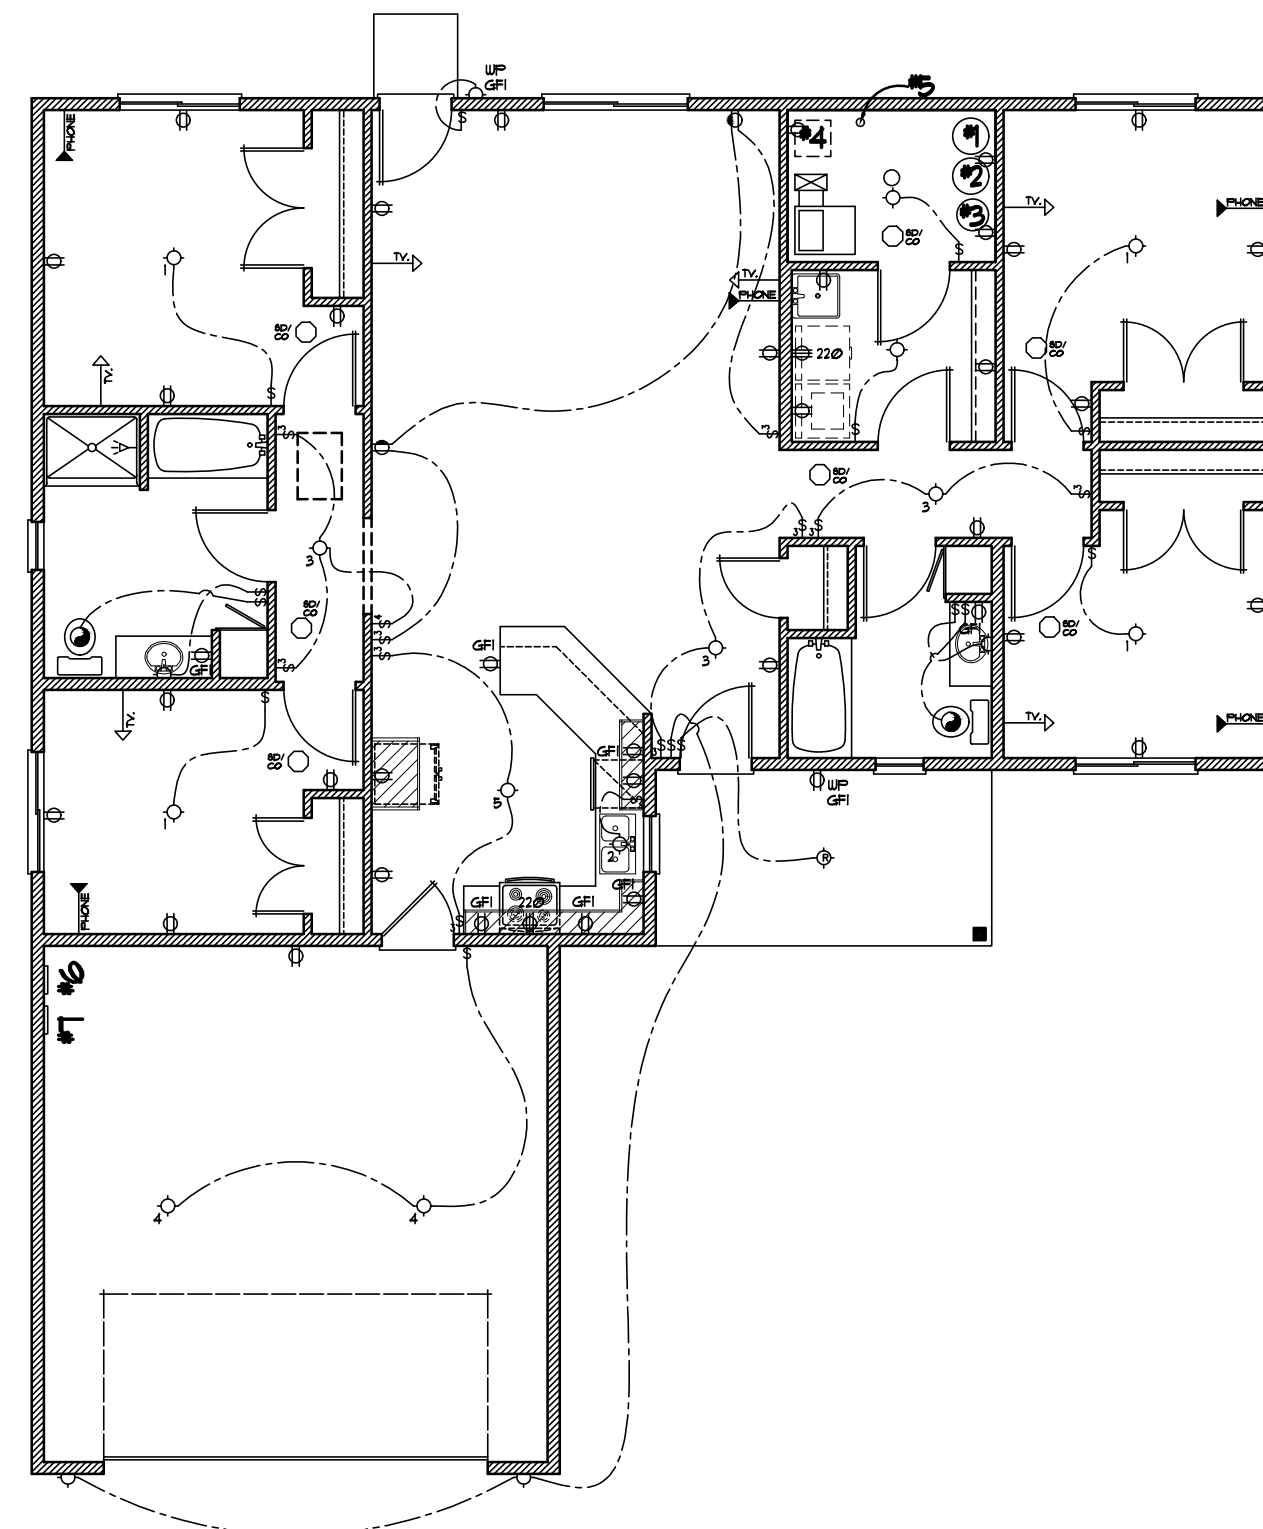

ELECTRICAL PLAN 1/8"=1'-0"

OFFICE: 763.757.5997
FAX: 763.757.4383
ANDOVER, MINNESOTA
WWW.CROIXDESIGN.COM

CROIX
DESIGN & DRAFTING, INC.

BUILT BY:
MILLE LACS BAND of OJIBWE

SHEET
5
of 7

CADD FILE #
17265-L

SPECIAL NOTICE:
CROIX DESIGN and DRAFTING, INC. ACCEPTS NO RESPONSIBILITY FOR ERRORS AND/OR OMISSIONS. THESE DRAWINGS ARE DESIGN CONCEPT ONLY. EVERY EFFORT HAS BEEN MADE TO PREPARE ACCURATE DRAWINGS. THE USER OF THESE DRAWINGS MUST CHECK ALL DIMENSIONS AND SPECIFICATIONS AND BE RESPONSIBLE FOR ANY CHANGES OR ADJUSTMENTS REQUIRED DURING ACTUAL CONSTRUCTION. NO REPRESENTATION IS MADE OR IMPLIED FOR ACCURACY.

TABLE R602.3(3) REQUIREMENTS FOR WOOD STRUCTURAL PANEL WALL SHEATHING USED TO RESIST WIND PRESSURE a,b,c

MINIMUM NAIL		MINIMUM WOOD STRUCTURAL PANEL SPAN RATING	MINIMUM NOMINAL PANEL THICKNESS (INCHES)	MAXIMUM WALL STUD SPACING (INCHES)	PANEL NAIL SPACING		MAXIMUM WIND SPEED (MPH)		
SIZE	PENETRATION (INCHES)				EDGES (INCHES O.C.)	FIELD (INCHES O.C.)	WIND EXPOSURE CATEGORY		
6d COMMON (2.0"x0.113")	1.5	24/0	3/8	16	6	12	110	90	85
8d COMMON (2.5"x0.131")	1.75	24/16	7/16	16	6	12	130	110	105
				24	6	12	110	90	85

FOR SI: 1"= 25.4mm, 1 mile per hour= 0.447 m/s

- a. Panel strength axis parallel or perpendicular to supports. three-ply plywood sheathing with studs spaced more than 16 inches on center shall be applied with panel strength axis perpendicular to supports
- b. Table is based on wind pressures acting toward and away from building surfaces per Section R3012. Lateral bracing requirements shall be in accordance with Section R602.10
- c. Wood structural panels with span ratings of Wall-16 or Wall-24 shall be permitted as an alternate to panels with a 24/0 span rating. Plywood siding rated 16'o.c. or 24'o.c. shall be permitted as an alternate to panels with a 24/16 span rating. Wall-16 and Plywood siding 16' o.c. shall be used with studs spaced a maximum of 16 inches on center.


NOTE!!!
APPROVED UPLIFT FRAMING CONNECTORS TO BE SPECIFIED BY TRUSS MANUFACTURER/ SUPPLIER TO PROVIDE A CONTINUOUS LOAD PATH TO A POINT WHERE UPLIFT FORCES ARE 1000LBS OR LESS (PER R602.3.5 AND PER SECTION R302.11

	WALL BRACING METHOD	DESCRIPTION
#1	CS-WSP	(CONTINUOUSLY SHEATHED WOOD STRUCTURAL PANEL) PER TABLE 602.3 (3)
#2	FFG	(PORTAL FRAMING AT GARAGE) SEE THE FFH DETAIL (THIS SHEET)

ALL BRACED PANEL LENGTHS GIVEN ARE TO BE TREATED AS MINIMUMS.

WIND EXPOSURE CATEGORY IS TO BE CATEGORY 'B' PER SECTION R3012.1.4

WIND SPEED RESISTANCE TO BE MEASURED LESS THAN OR EQUAL TO 90 MPH.

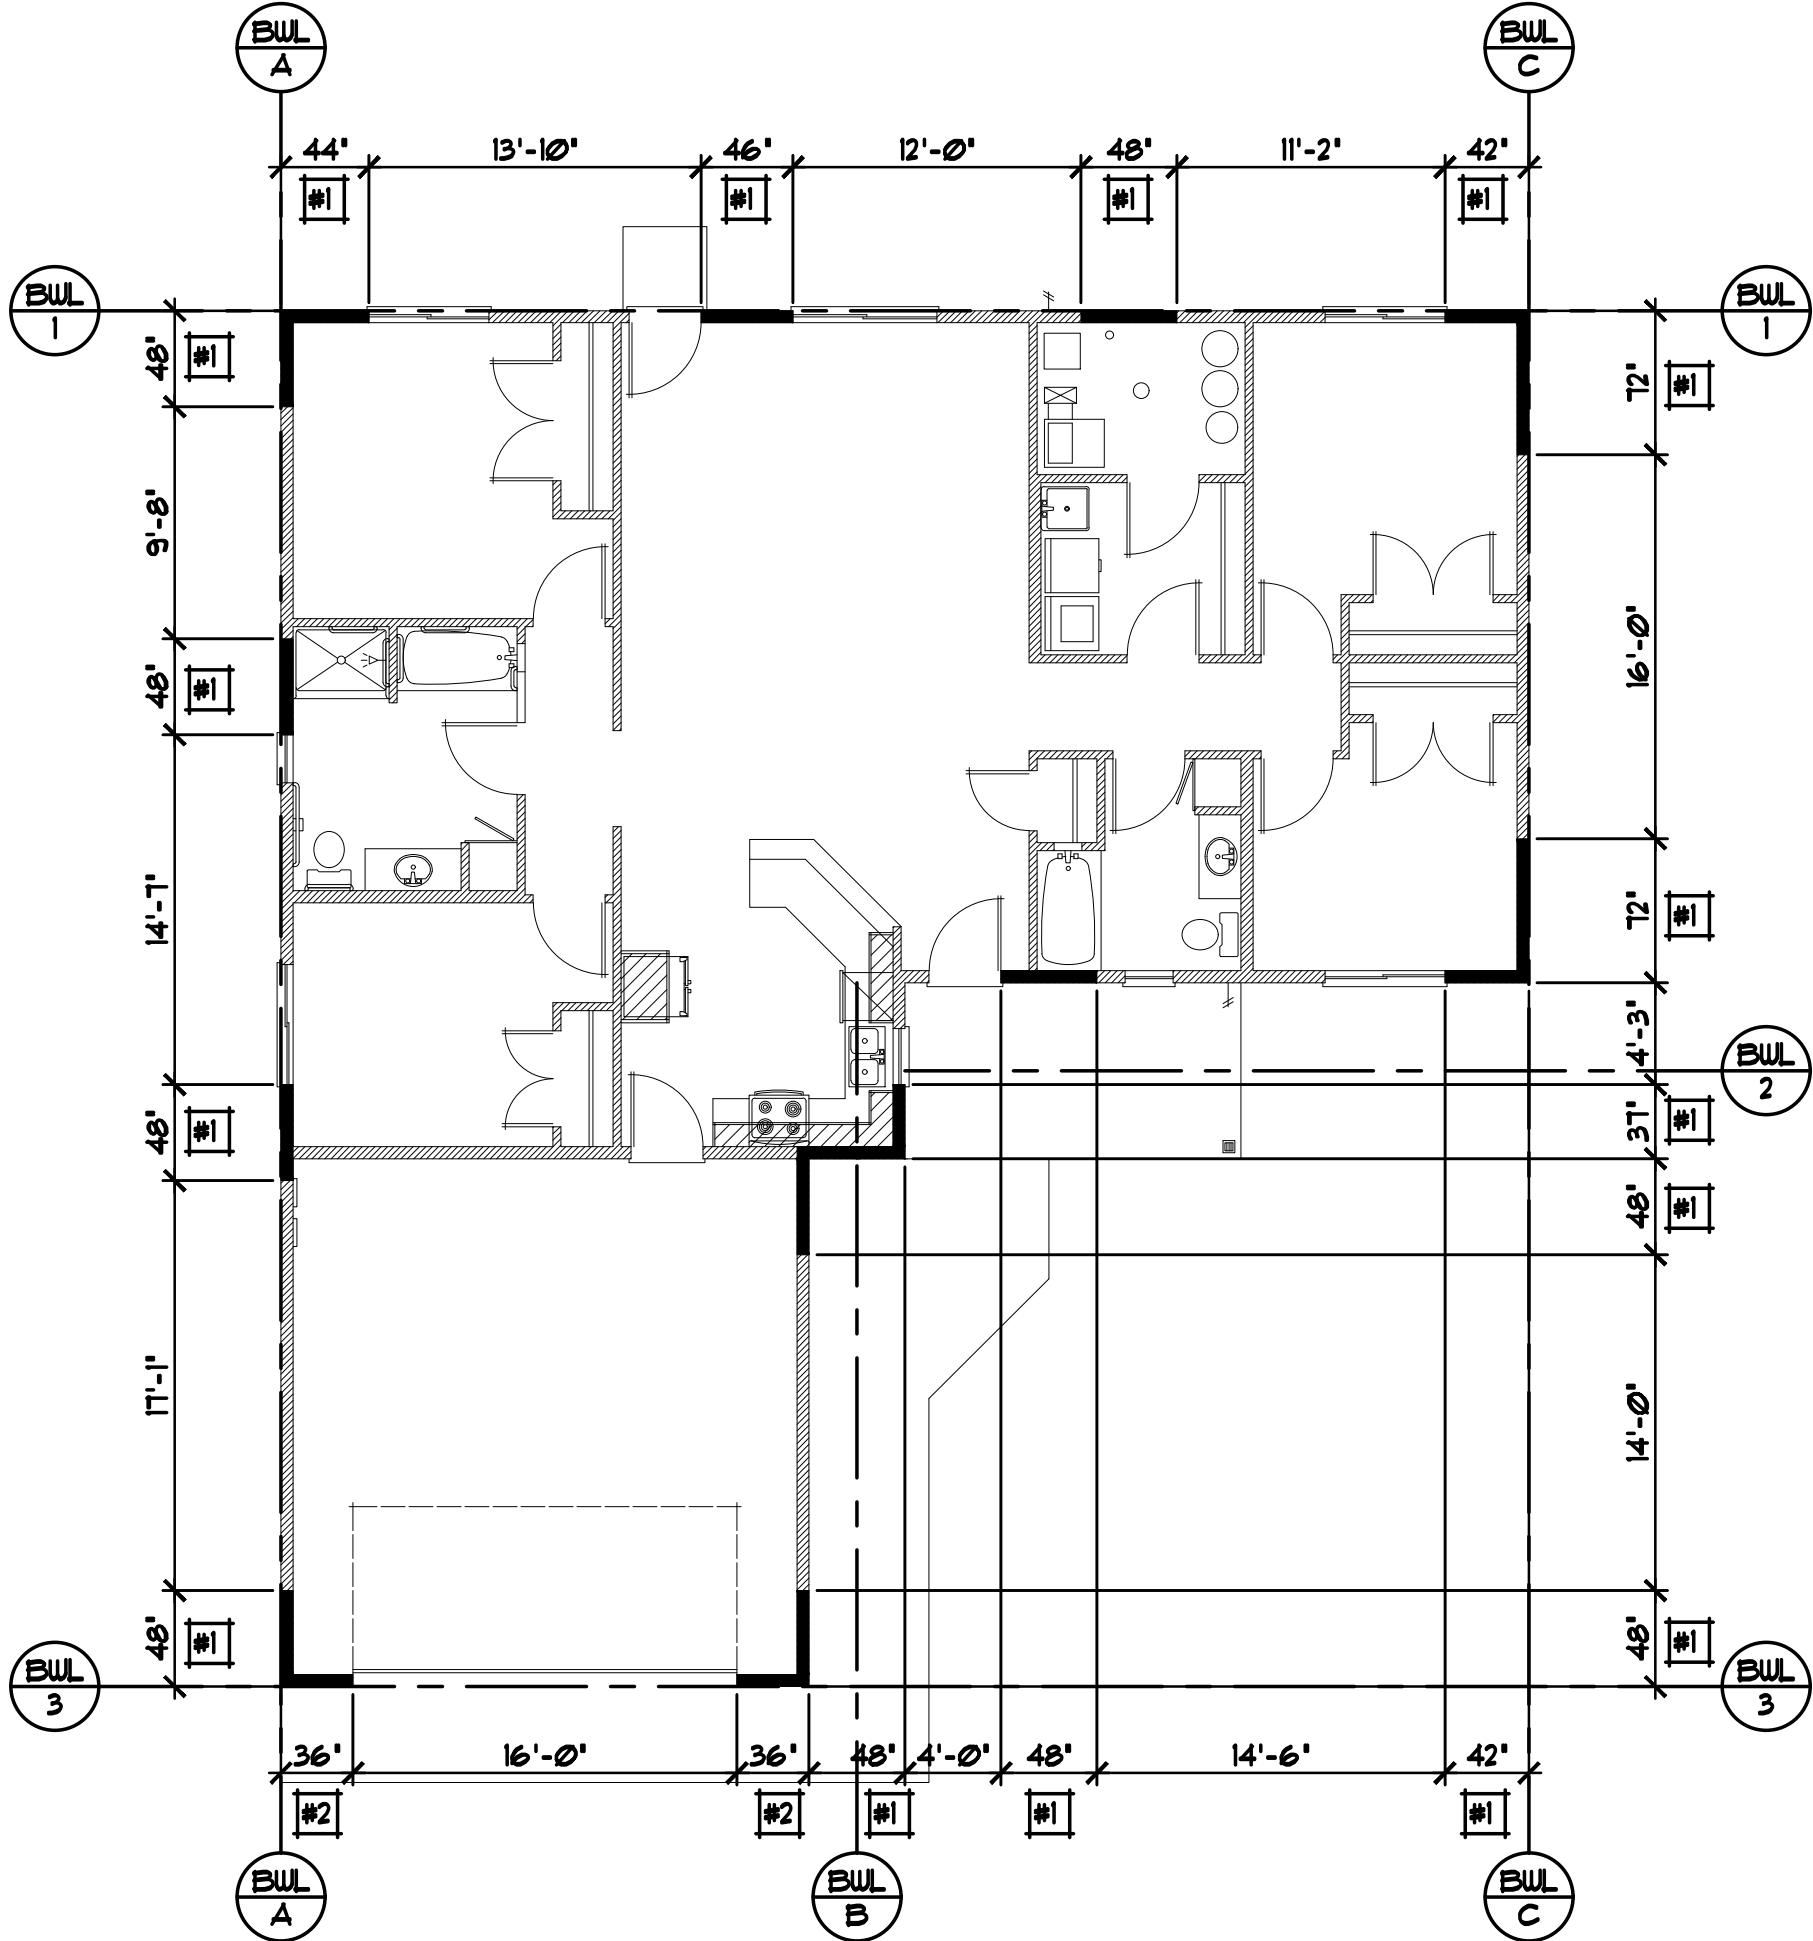


MAIN LEVEL WALL BRACING PLAN 1/8"=1'-0"

OFFICE: 763.757.5997
FAX: 763.757.4383
ANDOVER, MINNESOTA
WWW.CROIXDESIGN.COM




BUILT BY:
MILLE LACS BAND of OJIBWE


SPECIAL NOTICE:
CROIX DESIGN AND DRAFTING, INC. ACCEPTS NO RESPONSIBILITY FOR ERRORS AND/OR OMISSIONS. THESE DRAWINGS ARE DESIGN CONCEPT ONLY. EVERY EFFORT HAS BEEN MADE TO PREPARE THESE DRAWINGS TO THE BEST OF OUR KNOWLEDGE AND BELIEF. THE USER SHALL BE RESPONSIBLE FOR VERIFYING ALL DIMENSIONS, MATERIALS, AND METHODS OF CONSTRUCTION. NO REPRESENTATION IS MADE OR IMPLIED FOR ACCURACY.

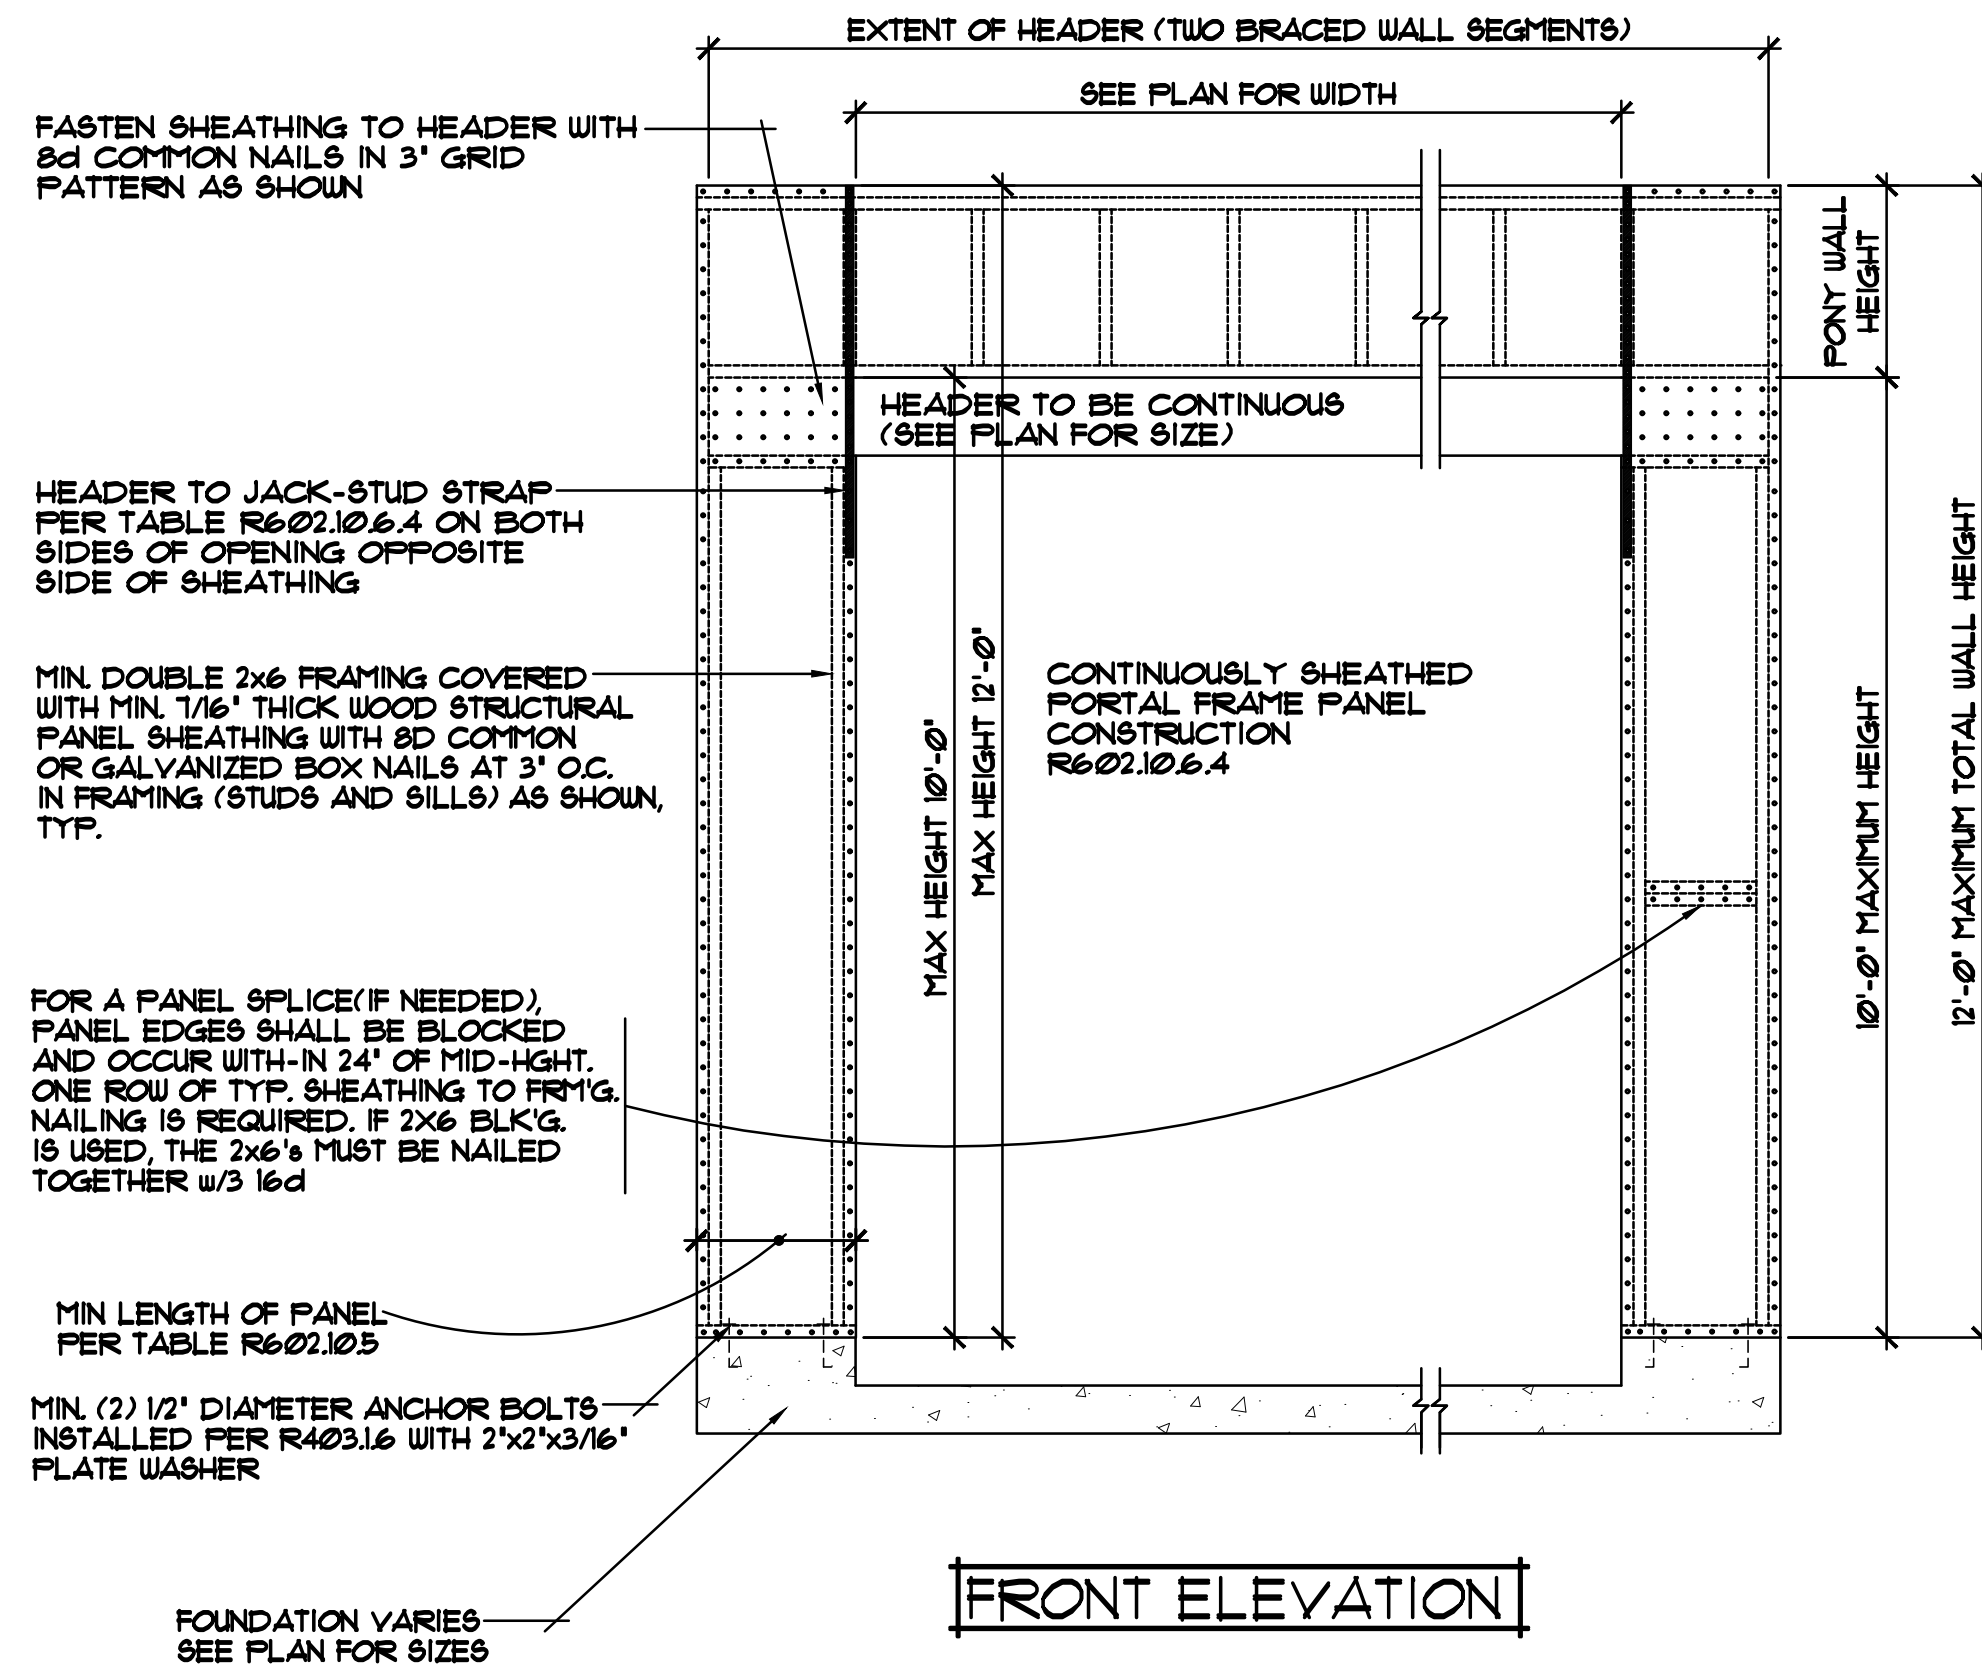

FRONT ELEVATION

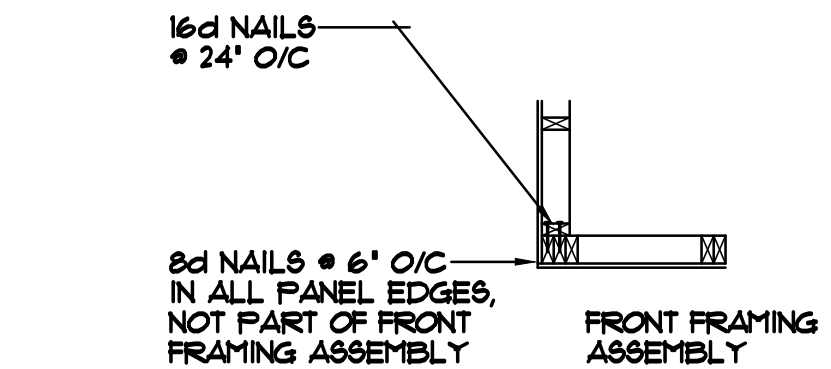

CORNER FRAMING DETAIL

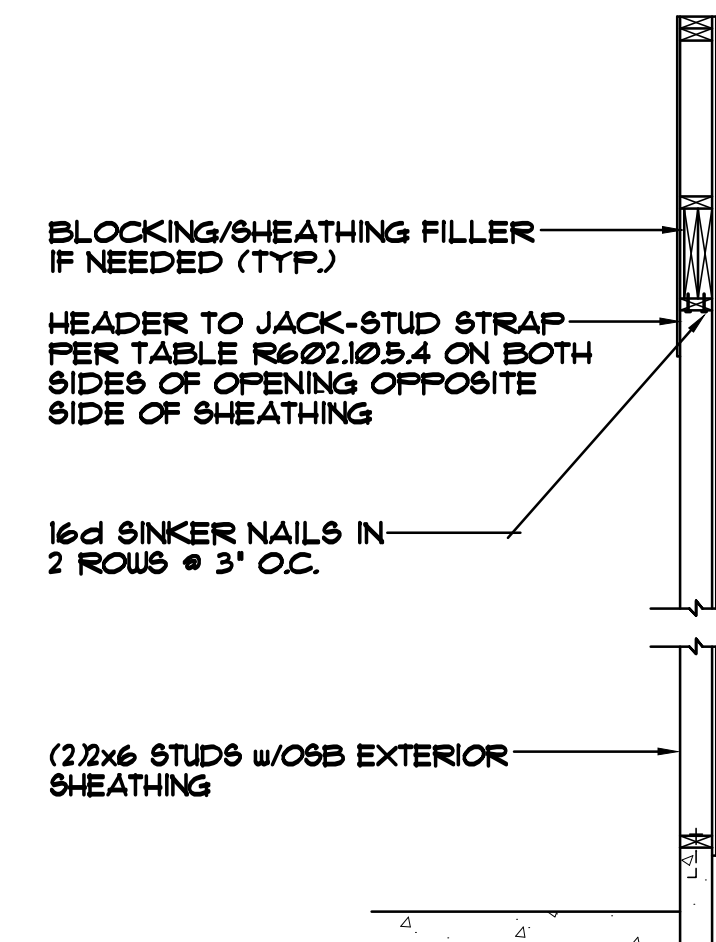

SIDE ELEVATION

PORTAL FRAMING AT GARAGE (SEISMIC CATEGORIES A, B, & C) 1/2"=1'-0"

SPECIAL NOTICE:

CROIX DESIGN and DRAFTING, INC. ACCEPTS NO RESPONSIBILITY FOR ERRORS AND/OR OMISSIONS. THESE DRAWINGS ARE DESIGN CONCEPT ONLY. EVERY EFFORT HAS BEEN MADE TO PREPARE THESE DRAWINGS TO THE BEST OF OUR KNOWLEDGE AND BELIEF. THE USER OF THESE DRAWINGS SHALL BE RESPONSIBLE FOR OBTAINING ALL NECESSARY PERMITS, CHECKS, AND APPROVALS. THE USER SHALL BE RESPONSIBLE FOR ANY CHANGES OR ADJUSTMENTS REQUIRED DURING ACTUAL CONSTRUCTION. NO REPRESENTATION IS MADE OR IMPLIED FOR ACCURACY.

OFFICE: 763.757.5997
FAX: 763.757.4383
ANDOVER, MINNESOTA
WWW.CROIXDESIGN.COM

CROIX
DESIGN & DRAFTING, INC.

BUILT BY:
MILLE LACS BAND of OJIBWE

SHEET
7
of 7
CADD FILE #
17265-L